


ALL DRAWINGS AND DIMENSIONS MUST BE CORRELATED BEFORE ORDERING OR BUILDING WORK COMMENCES. ANY DIFFERENCES MUST BE BROUGHT IMMEDIATELY TO THE ATTENTION OF THE ARCHITECT WHO WILL MAKE A DECISION. WORK SHOULD ONLY BE CARRIED OUT TO DIMENSIONS SHOWN AND DRAWINGS SHOULD NOT BE SCALED. IF ANY ADDITIONAL DIMENSIONS IS NEEDED CONTACT THE ARCHITECT. ALL WORK TO BE CARRIED OUT IN COMPLIANCE WITH NATIONAL BUILDING REGULATIONS. COPYRIGHT IS RESERVED ON ALL DRAWINGS AND DESIGNS.

ELECTRICAL LEGEND:

	CEILING LIGHT POINT
	FLOOR MOUNTED LIGHT POINT
	WATERPROOF CEILING LIGHT POINT
	WALL LIGHT POINT
	WATERPROOF WALL LIGHT POINT
	RECESSED LOW VOLTAGE LIGHT
	WATERPROOF RECESSED LOW VOLTAGE LIGHT
	FLOODLIGHT
	FOOTLIGHT
	FLUORESCENT LIGHT
	DISTRIBUTION BOARD
	ISOLATION SWITCH
	SINGLE/DOUBLE PLUGPOINT 300mm AFFL
	SINGLE/DOUBLE PLUGPOINT 100mm ABOVE FFL
	WATERPROOF PLUGPOINT 300mm AFFL
	CLEAN POWER SOCKET OUTLET
	THREE DIVISION POWER SKIRTING
	TELEPHONE POINT
	FAX POINT
	DATA POINT
	STOVE POINT
	TELEVISION POINT
	LIGHT SWITCH @ 1100mm AFFL
	2 WAY LIGHT SWITCH
	LIGHT SWITCH WITH DIMMER
	HOB EXTRACTOR
	HOT WATER CYLINDER
	HEATED TOWEL RAIL
	BELL/BELL PUSH
	SHAVING POINT
	GARAGE DOOR MOTOR & LIGHT COMBINATION
	FLOOR MOUNTED PLUGPOINT
	CEILING FAN
	UNDERFLOOR HEATING CONTROL
	AIRCONDITIONER CONTROL
	SPEAKER OUTLET IN WALL
	SPEAKER OUTLET IN CEILING
	PHOTOCELL
	BURIED FLOODLIGHT
	TILTING RECESSED LOW VOLTAGE LIGHT
	RECESSED EYEBALL (12V)
	UNDERWATER LIGHT
	STRIP LIGHT UNDER HIGH LEVEL CUPBOARD
	GARDEN LIGHT
	ALARM CONTROL PANEL
	INTERCOM SYSTEM
	PIR SENSOR
	SECURITY CAMERA
	MOVEMENT SENSITIVE SECURITY LIGHTING
	IRRIGATION CONTROL POINT
	AIRCON CONDENSER
	AIRCON
	UNDER COUNTER WARM WATER CYLINDER
	CEILING MOUNTED HEATING LIGHT

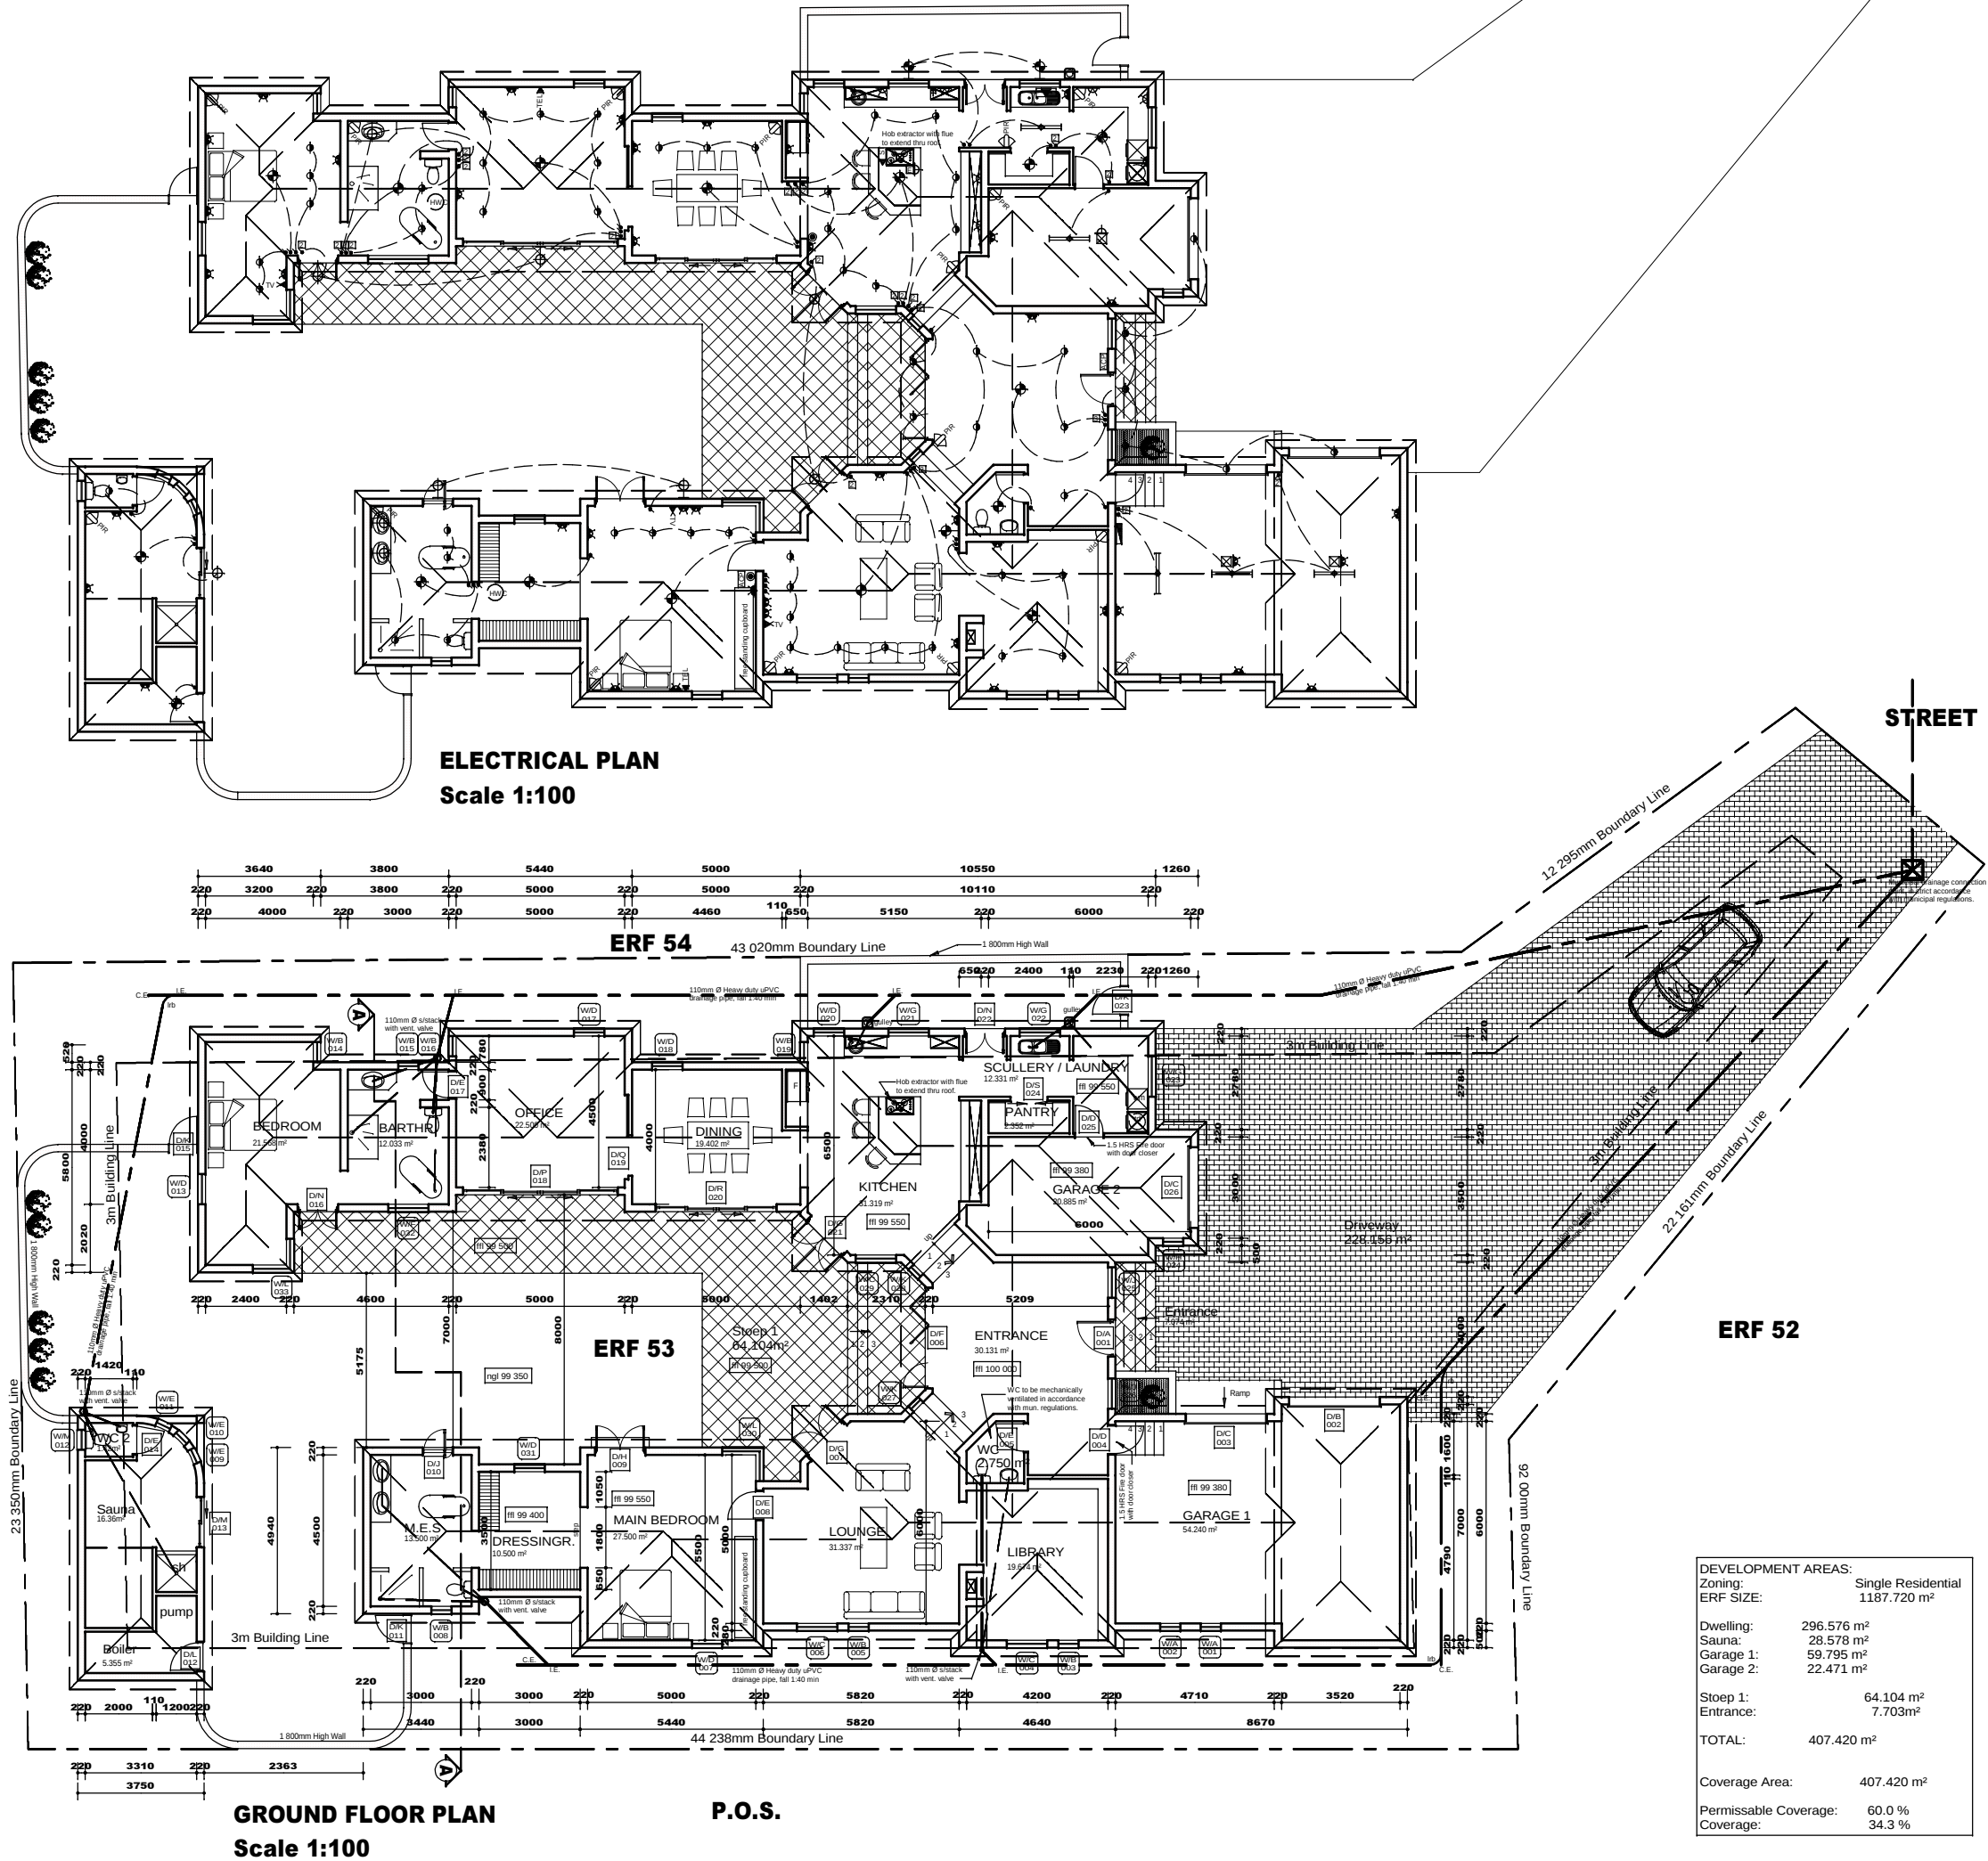

AMENDMENTS		
No.	DATE	DESCRIPTION

COBUS LÖTTER ARCHITECTS cc
P.O. BOX 700
NALVIS BAY
TEL. 084 807654
FAX. 084 800303

C.L.A. BUILDING
84 THEO-BEN GURIRAB STREET
NALVIS BAY - NAMIBIA
EMAIL: clobus@vod.com.na
REG. NO. 0683/27447/23

CLIENT APPROVAL:

PROJECT
PROPOSED NEW RESIDENCE FOR
Mr. P. Witt on erf 53
Rossmund, Swakopmund

DRAWING:
GROUND FLOOR PLAN
and ELECTRICAL PLAN

SCALE:	DATE & TIME	DRAWN:	CHECKED:
1:100	3 Feb 2015 10:09:11 AM	clc	

PROJECT NO:	DRAWING NO:	REVISION:
PW 22	2.01	A

Client Drawing Description:
Directory, Title, Extension
1/2/2013 clc drawings 2013 projekel - wittler 53 - witt - construction.dwg